
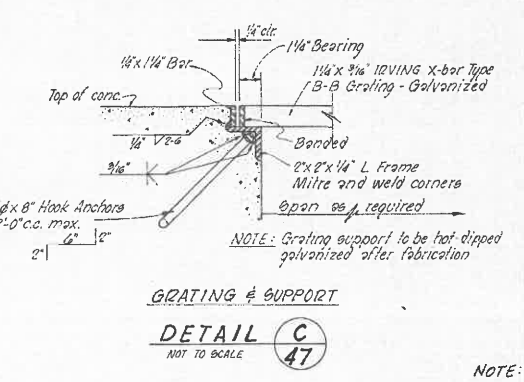
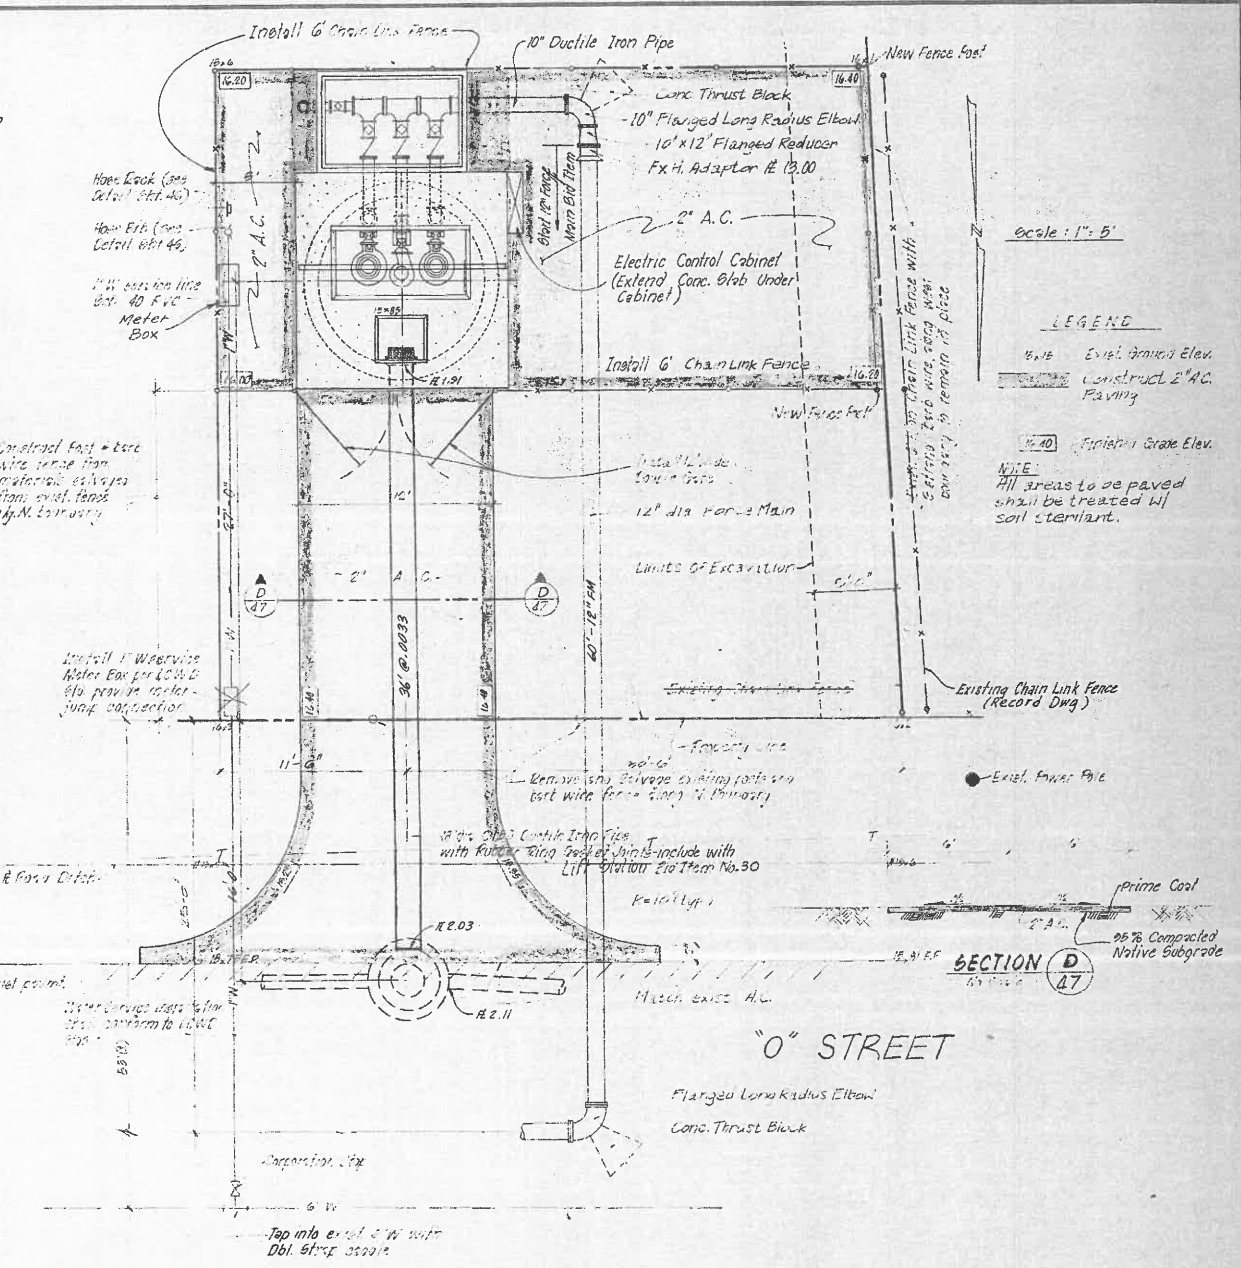
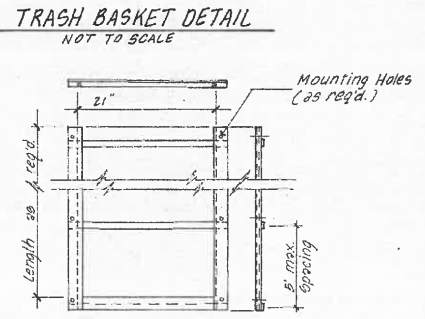
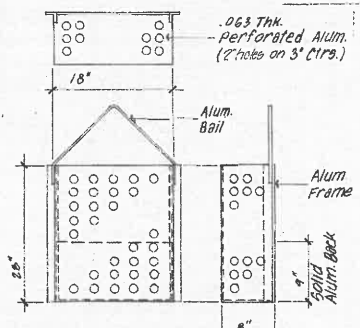
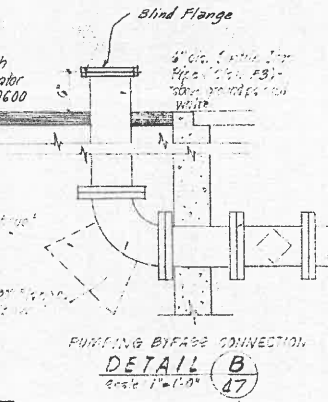
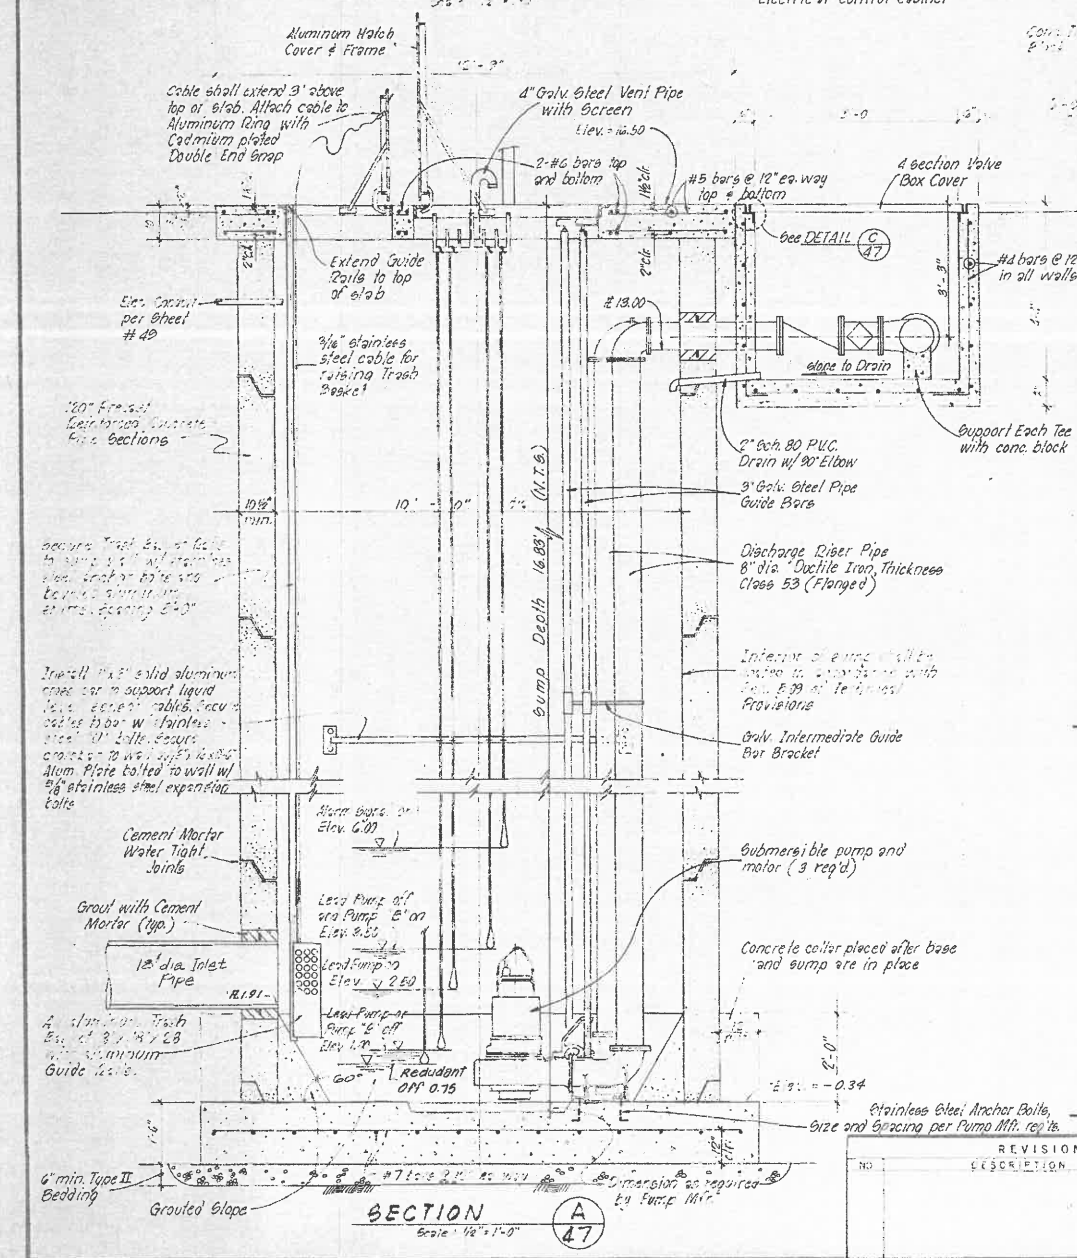


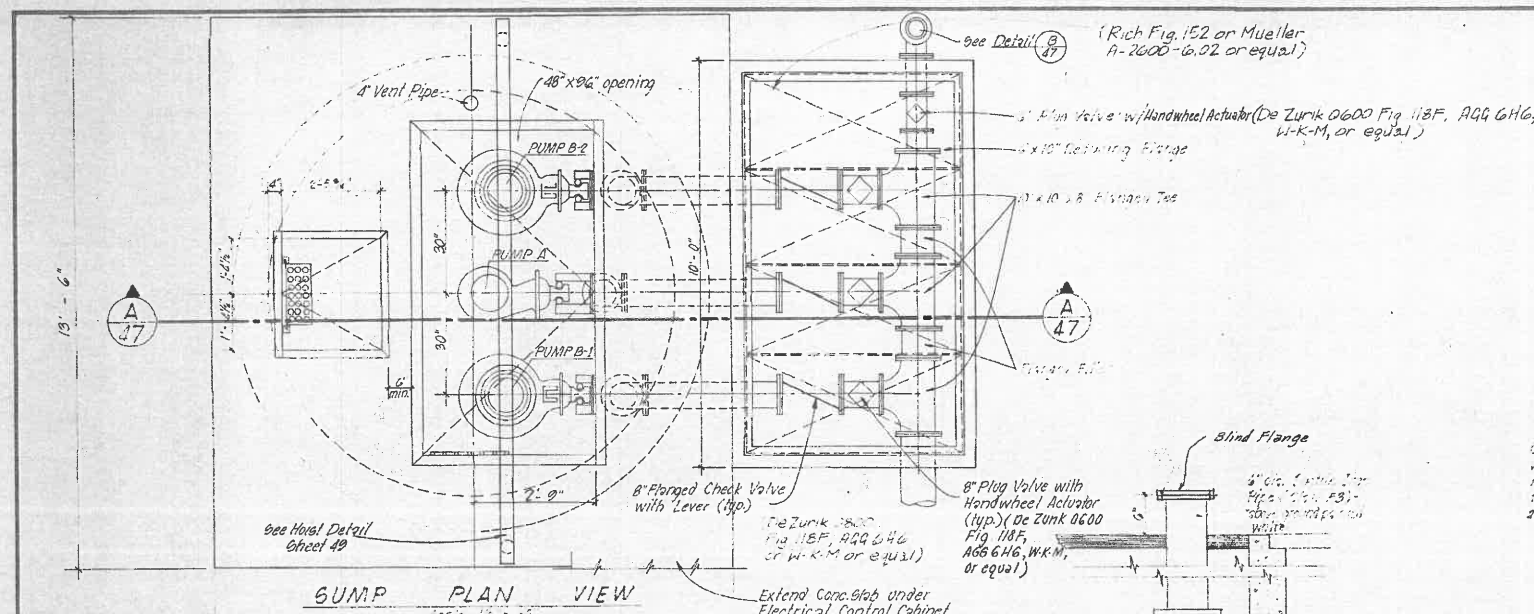

Scale: 1" = 5'

LEGEND

4.15 Existing Ground Elev.

Construct 2" A.C. Paving

4.20 Finished Grade Elev.

NOTE: All areas to be paved shall be treated w/ soil stabilant.

NOTE: Refer to sheet No. 49 for Electrical and Control Plan.

NO.	REVISIONS	DATE	BY


R. W. SIEGFRIED & ASSOCIATES
 CONSULTING CIVIL ENGINEERS
 4045 CORONADO AVENUE, STOCKTON, CALIFORNIA 95204
Donald R. Schenker
 R.C.E. No. 8536

JOB NO. 4514-A-2
 DATE: Aug. 1985
 F.B. NC 511
 DRAWN: D.E.K.
 DESIGN: L.M.S., R.G.C.
 CHECKED: A.R.S.


LATHROP COUNTY WATER DISTRICT
LATHROP SANITARY SEWER PROJECT
"O" STREET LIFT STATION

SHEET
47
 OF 49
 FILE NO.
 G-2803

ONE LINE DRAWING

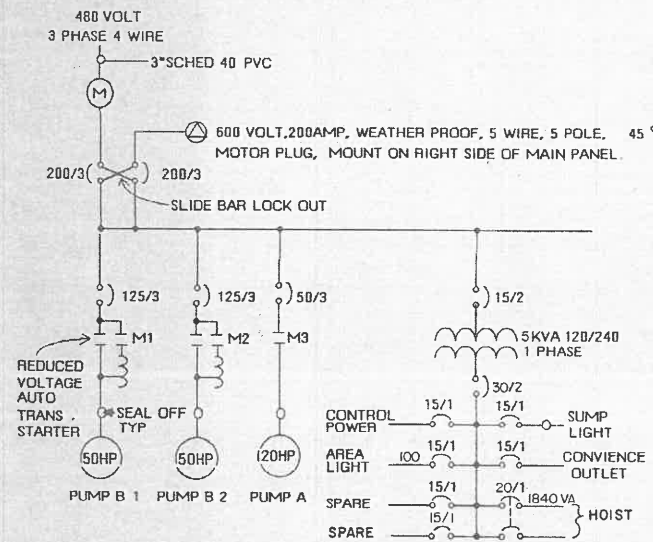



SUMP LIGHT
EXPLOSION PROOF FIXTURE
W/150 W ROUGH SERVICE
INCANDESCENT LIGHT

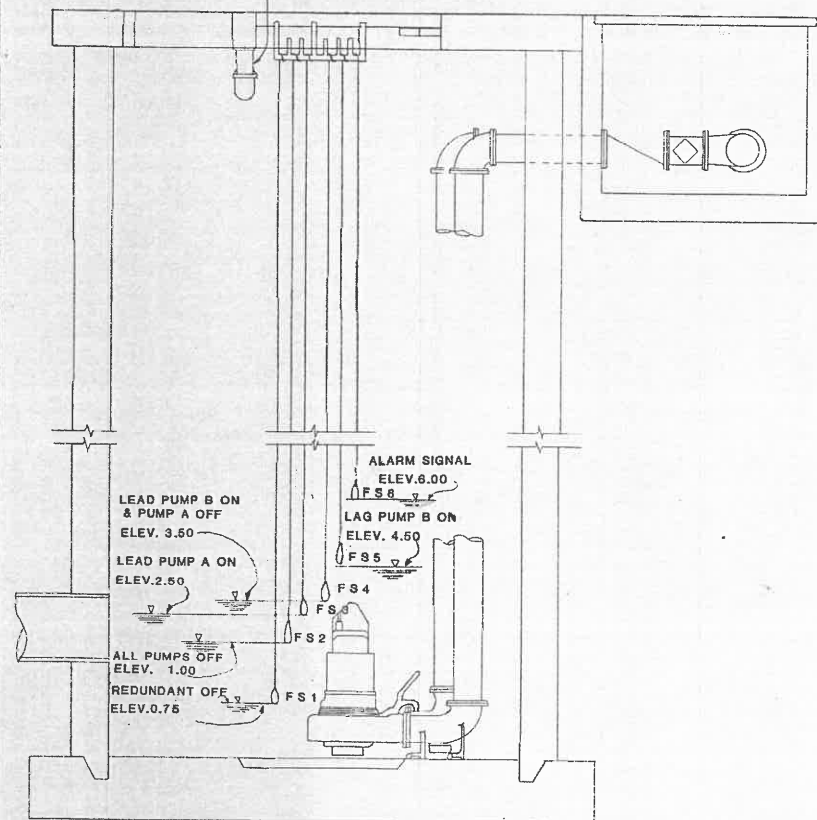

SECTION A-A

SCALE 1/2" = 1'0"



PUMP ELEMENTARY CONTROL DIAGRAM

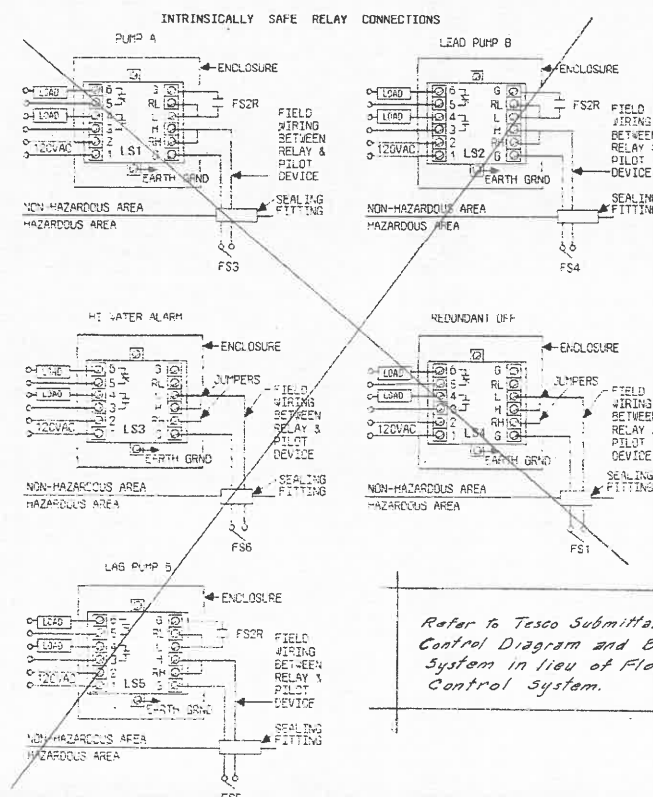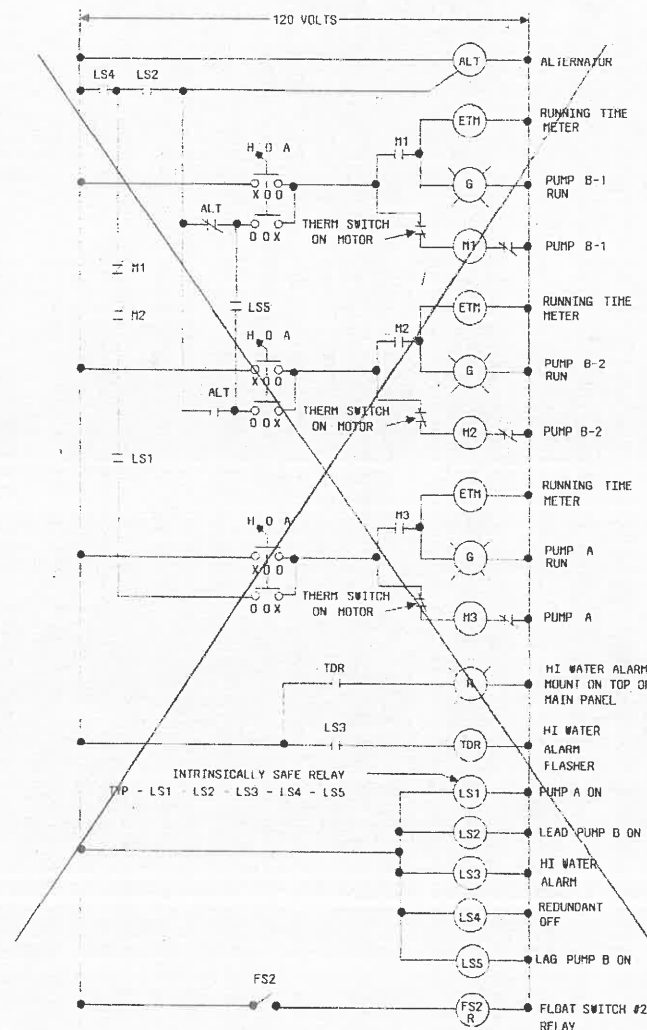

Refer to Tesco Submittal for
Control Diagram and Bubbler
System in lieu of Float
Control System.

HALF SECTION HOIST DETAIL

SCALE 1/2" = 1'0"

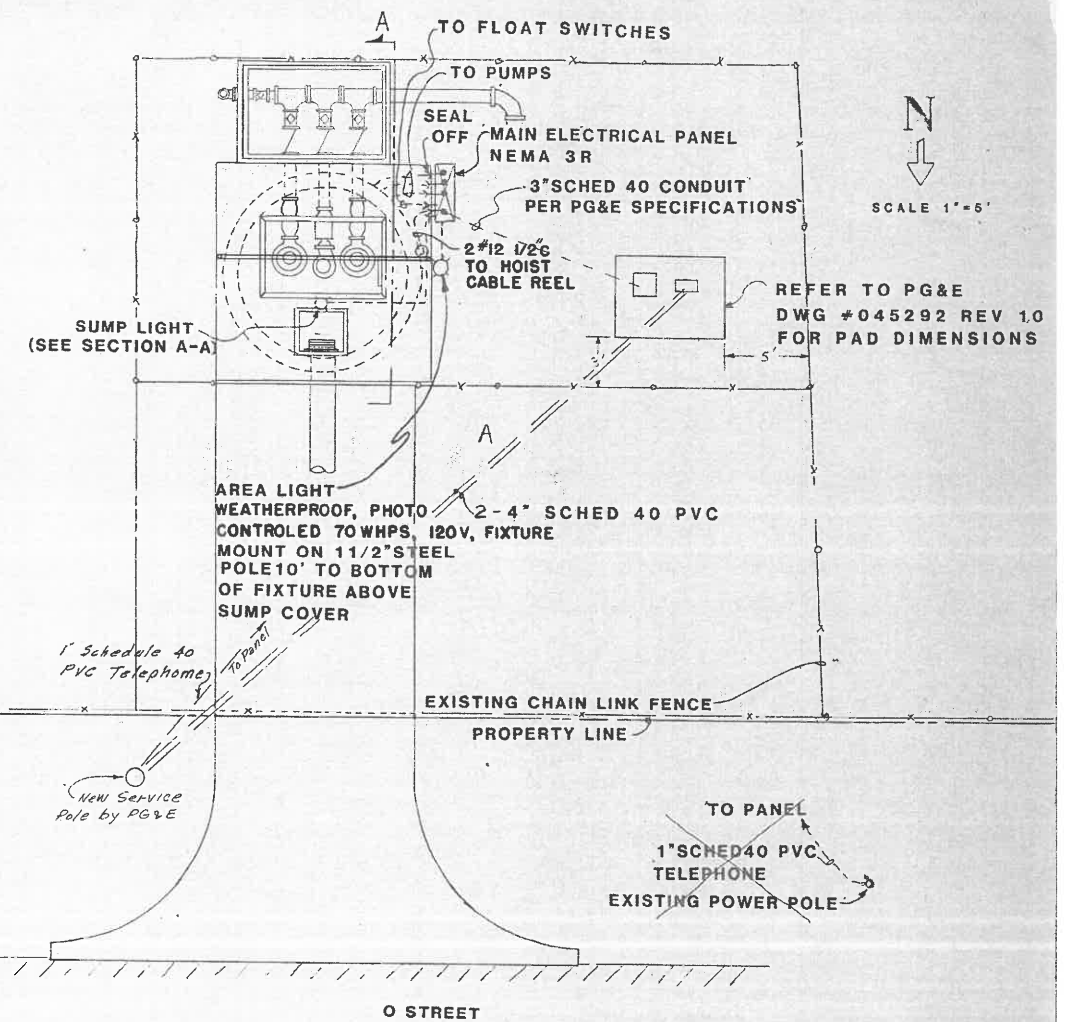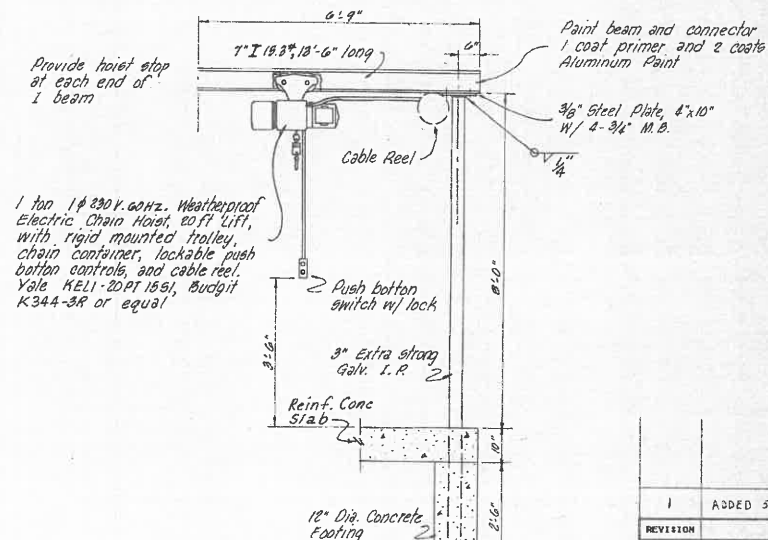

RECORD DRAWINGS

REVISION	DESCRIPTION	DATE	BY
1	ADDED 50 HP AND NEW XFMR PAD	6/21/85	J.W.O.
LATHROP COUNTY WATER DISTRICT			
LATHROP SANITARY SEWER PROJECT			
TITLE ELECTRICAL - "O" STREET LIFT STATION			
SCALE AS NOTED	DATE 3/18/85	DRAWN BY C.K.A.	DRAWING NUMBER
ONETO & ARTHUR ENGINEERING			
(209) 464-4775			
922 N. CENTER ST., STOCKTON, CA. 95202			
MAILING ADDRESS P.O. BOX 967, STOCKTON, CA. 95201			